


This drawing is the sole copyright of BWP and is issued on the terms that it will not be reproduced or copied in whole or part nor will any information be furnished from it without written authority BWP is the trading name of Bellamy Wallace Partnership LLP


SURFACE WATER DRAINAGE KEY:

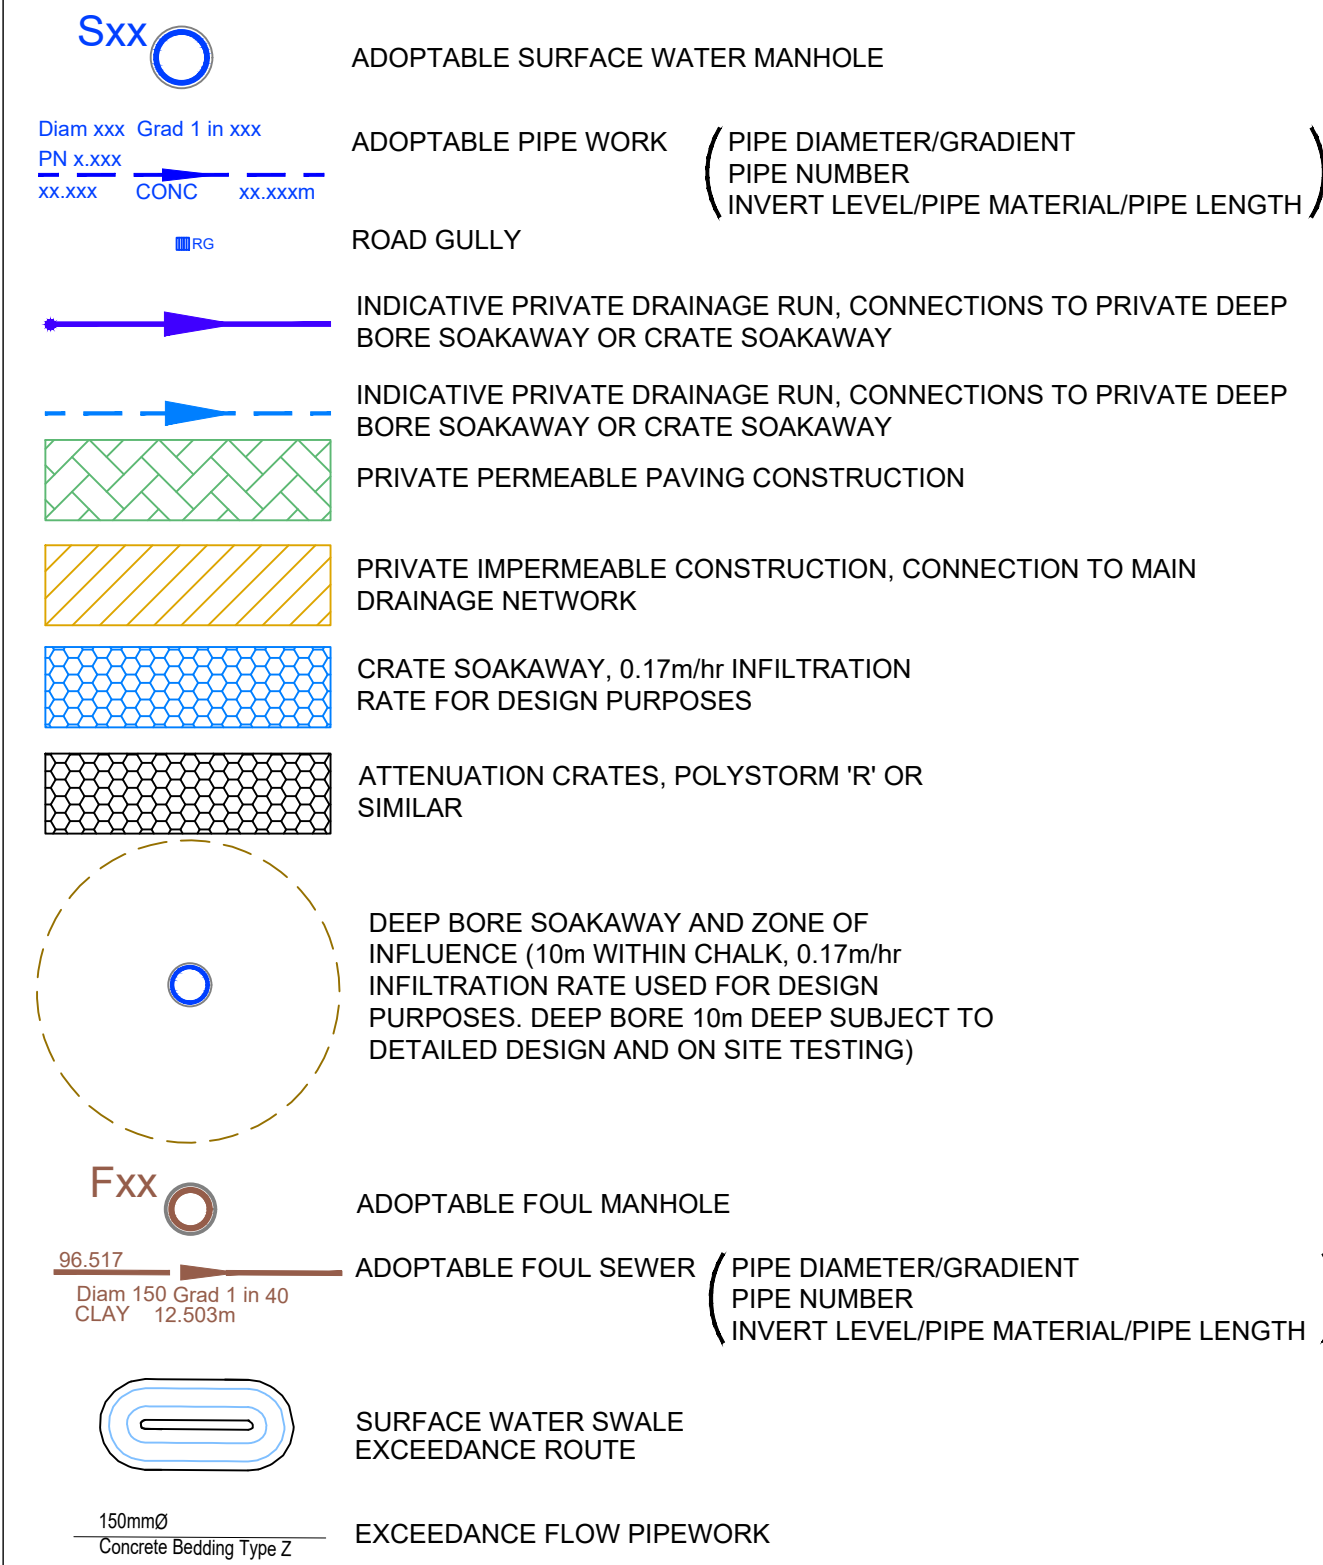

THIS DRAWING IS TO BE READ IN CONJUNCTION WITH ALL THE ENGINEER'S AND OTHER SPECIALISTS DRAWINGS AND SPECIFICATIONS.

DO NOT SCALE THIS DRAWING. WRITTEN DIMENSIONS ONLY SHALL BE USED. ANY DISCREPANCIES MUST BE REPORTED TO THE ARCHITECT/ENGINEER.

SHEET 1

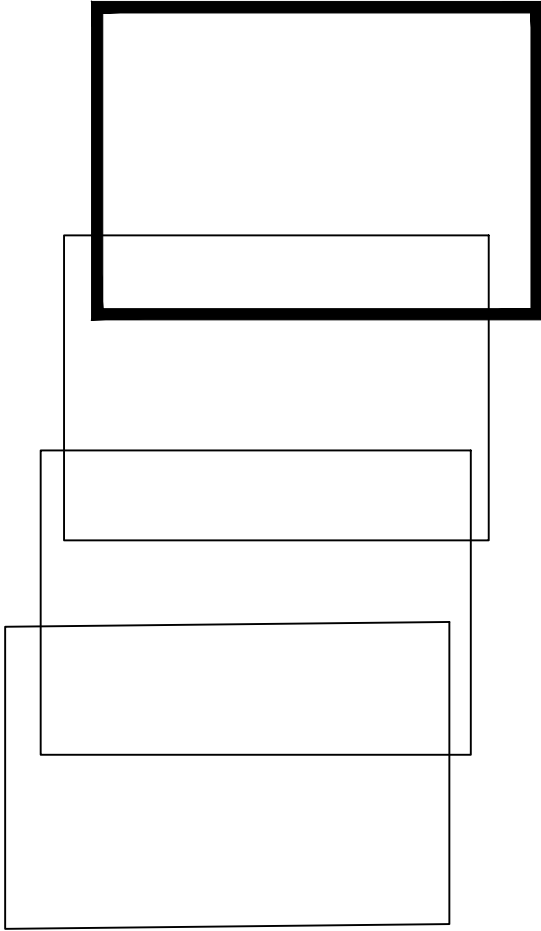

KEY PLAN

Bellamy Wallace Partnership
Consulting Structural Engineers

E-mail: kent@bwp-eng.co.uk

Grange House
Beardsted Green Business Centre
The Green, Beardsted, Maidstone
Kent, ME14 4DZ

Tel: 01622 630675
BWP PROJECT REF K2275

PROJECT EAST HILL,
CHATHAM, PHASE 1

TITLE SURFACE WATER AND FOUL
DRAINAGE LAYOUT
SHEET 1 OF 4

REV	DATE	DRAWN	DESCRIPTION	CHECK	APPR.
P01	07.12.22	CJH	PRELIMINARY ISSUE	CJH	SW
P02	11.01.23	CJH	SWALES MODELLED, FOUL ADDED	CJH	SW
P03	13.01.23	CJH	DESIGN DETAILS ADDED, SOAKAWAYS UPDATED	CJH	SW
P04	19.01.23	CJH	LANDSCAPE DETAILS UPDATED	CJH	SW

Taylor Wimpey South East
103 Tonbridge Road,
Hildenborough,
Tonbridge,
Kent,
TN11 9HL,
Tel: 01732 836000
Web: www.taylorwimpey.co.uk

Taylor Wimpey

CHECKED BY	DATE	APPROVED BY	DATE
DRN BY	SCALE	DRAWING NUMBER	REV
DATE			

CJH 1:250 K2275-CIV-0101 P04
JAN 2023