


THIS DRAWING IS COPYRIGHT © Western Design Ltd 2019

REPRODUCING THESE DRAWINGS BY PRINTING OR COPYING MAY LEAD TO ERRORS, PLEASE REFER TO SCALE BAR. DO NOT SCALE OFF THESE DRAWINGS FOR CONSTRUCTION PURPOSES. IF ANY DISCREPANCIES ARE FOUND, PLEASE CONTACT WESTERN DESIGN ARCHITECTS IMMEDIATELY.

DESIGNERS RISK ASSESSMENT- HEALTH AND SAFETY THE CONSTRUCTION (DESIGN AND MANAGEMENT) REGULATIONS 2015

Where appropriate, for significant hazards specific to the project please refer to drawing CDM01

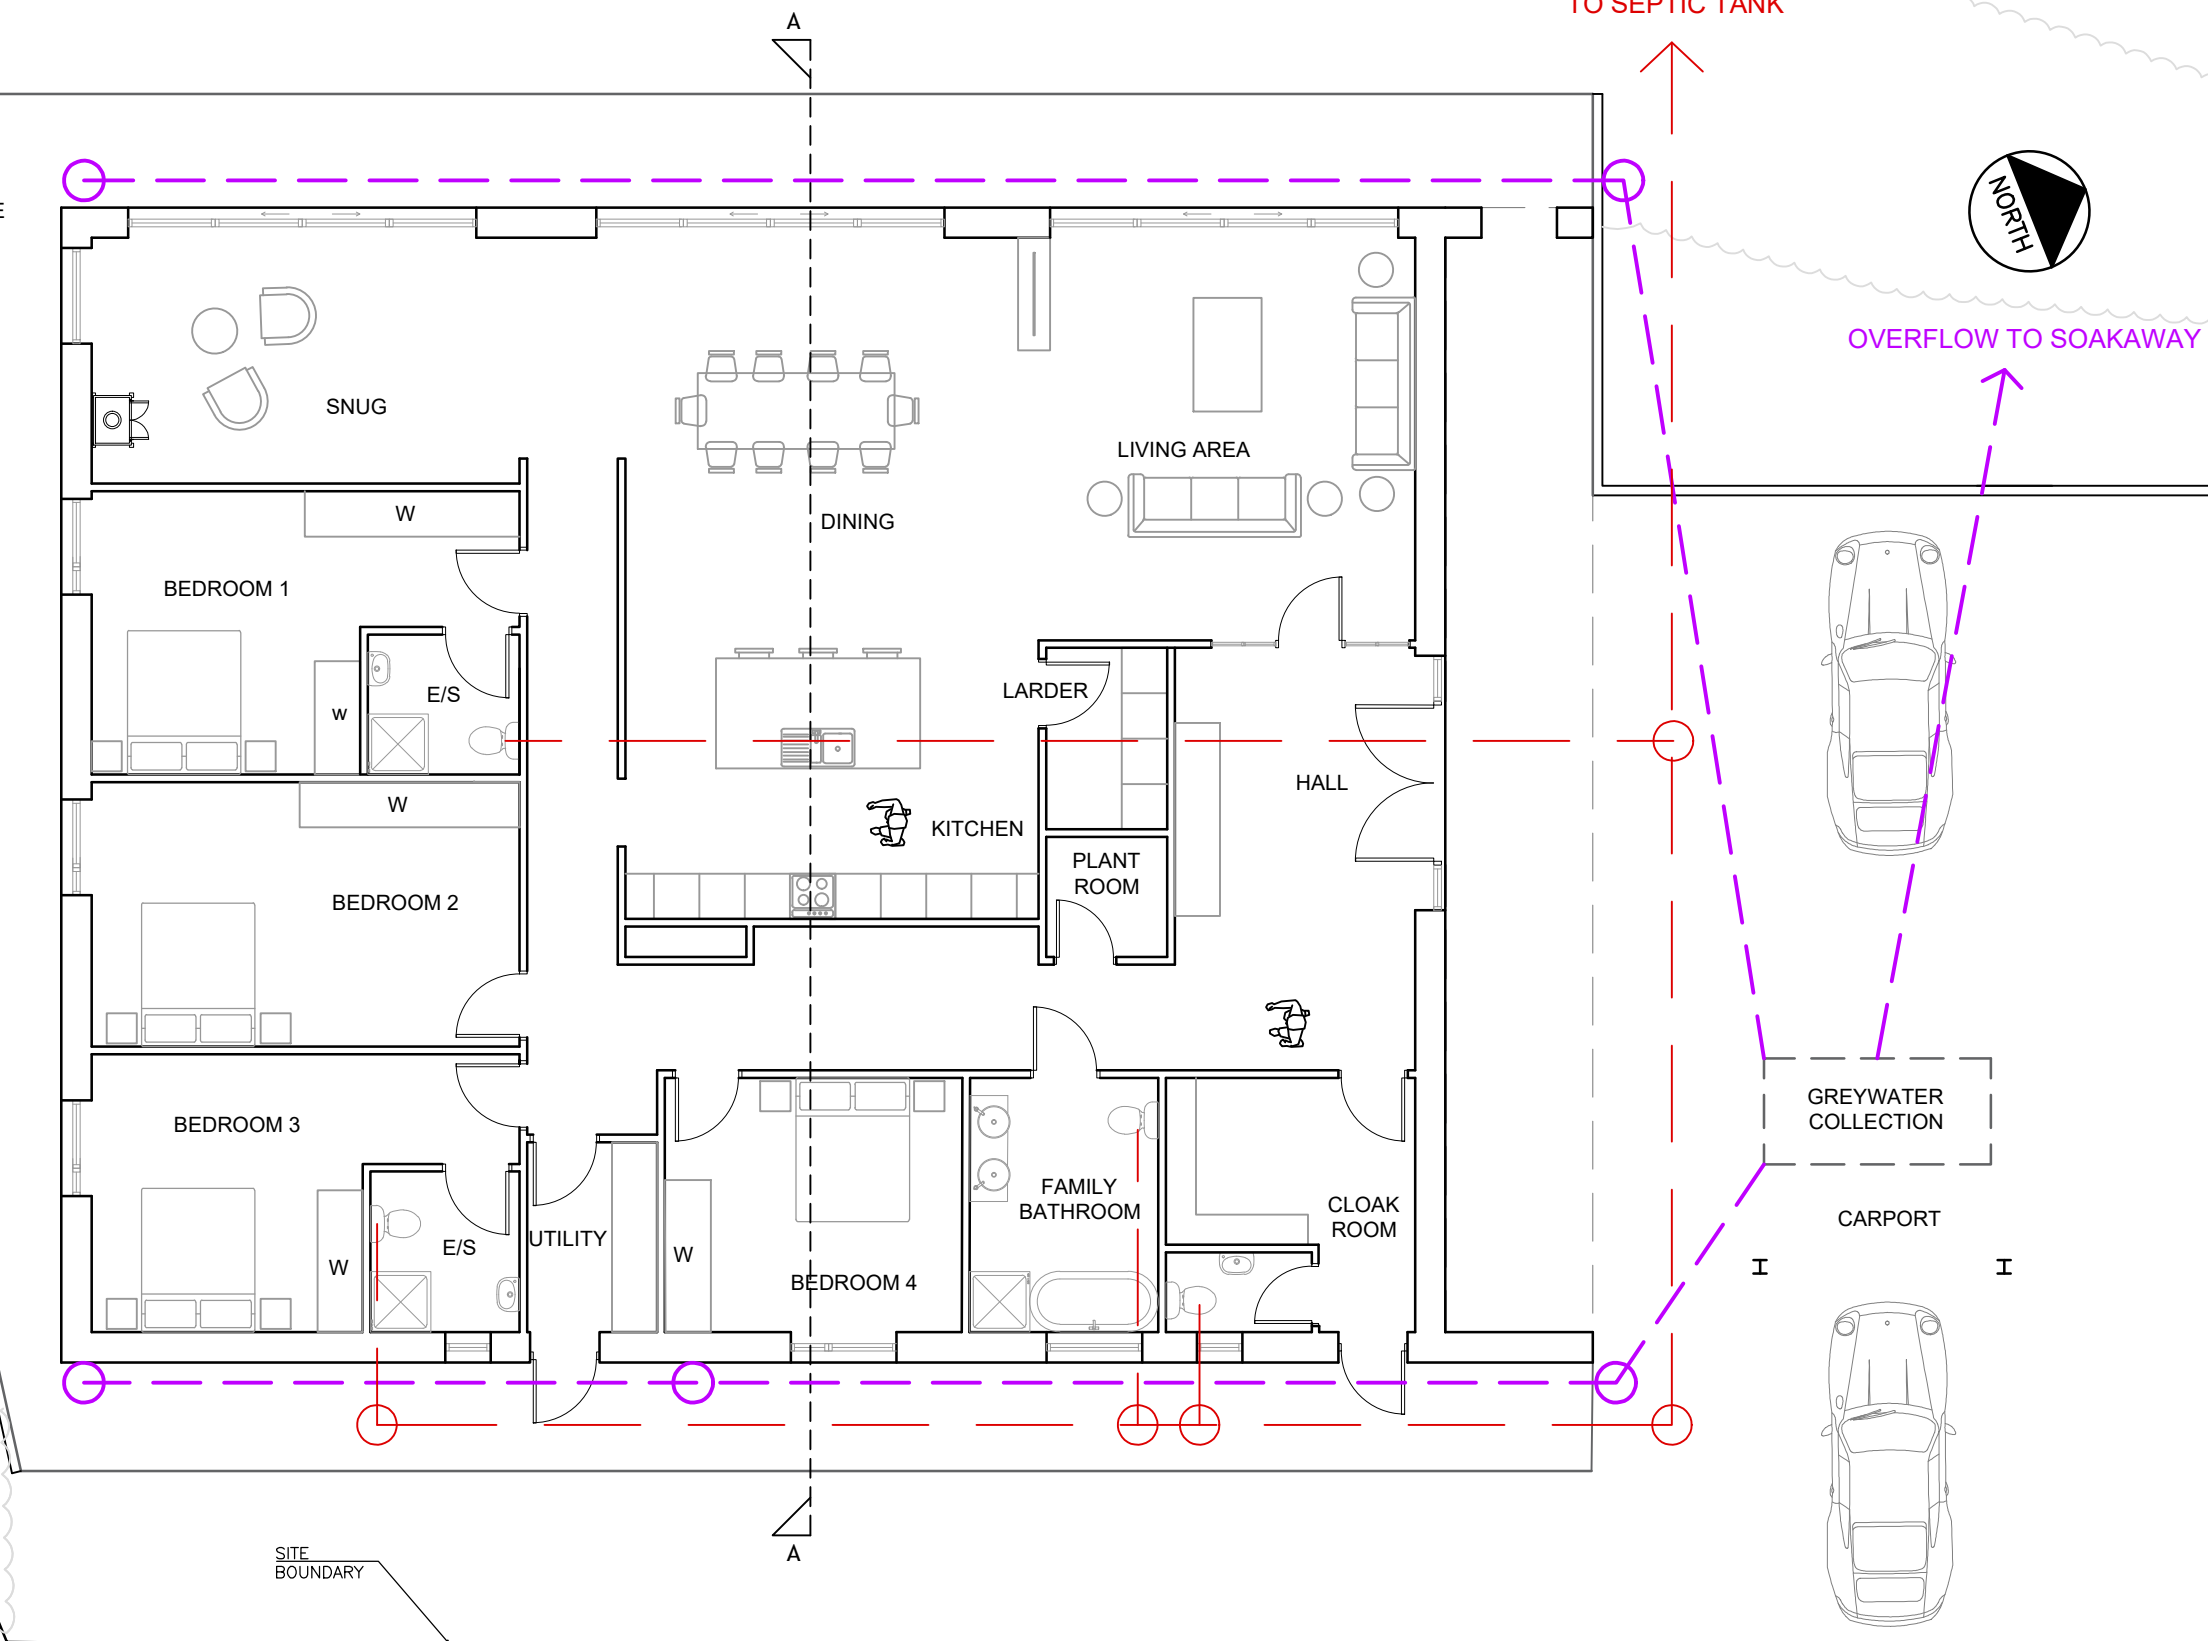

REV.	DETAILS	BY	CKD	DATE
-	-	-	-	-

**WDA**  
westerndesignarchitects.com

Western Design Architects  
12 The Granary, Hinton Business Park, Tarrant Hinton, Dorset, DT11 8JF  
T:01258 830675 E:info@westerndesign.co.uk

CLIENT  
**Mr & Mrs Kedge**

PROJECT  
**Barn at Slyers Lane, Stinsford**

DRAWING TITLE  
**Proposed Drainage Layout**

DATE <b>07.05.2020</b>	DRAWN BY <b>MT</b>	CHECKED BY <b>JT</b>
---------------------------	-----------------------	-------------------------

SCALE <b>1:100@A3</b>	JOB NO. <b>1819150</b>
--------------------------	---------------------------

DRAWING NO. <b>16</b>	REVISION <b>-</b>
--------------------------	----------------------

**FOUL WATER** — — — —

**SURFACE WATER** - - - - -

**PLANNING**